


DPW PROJECT NO. 24217  
 Morrison Center Restroom Remodel -  
 Design Professional RFQ

ORCHESTRA PIT PLAN  
 91.00' LEVEL

FLOOR PLAN  
 100.00' LEVEL

LOMBARD-CONRAD, ARCHITECTS  
 A.I.A.  
 Consultants  
 Phone 208-345-6677

Planners  
 Architects  
 102 South 27th Street, Boise, Idaho 83706

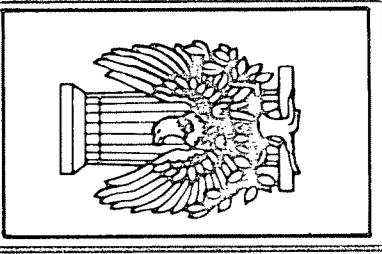


MORRISON CENTER  
 FOR THE FINE  
 AND PERFORMING ARTS  
 BOISE STATE UNIVERSITY  
 BOISE IDAHO

job no.	79/27
date	AUGUST 1981
drawn by	checked by
revisions	date

sheet no.  
 1  
 of 4 sheets


SCALE 1/16" 1'-0"

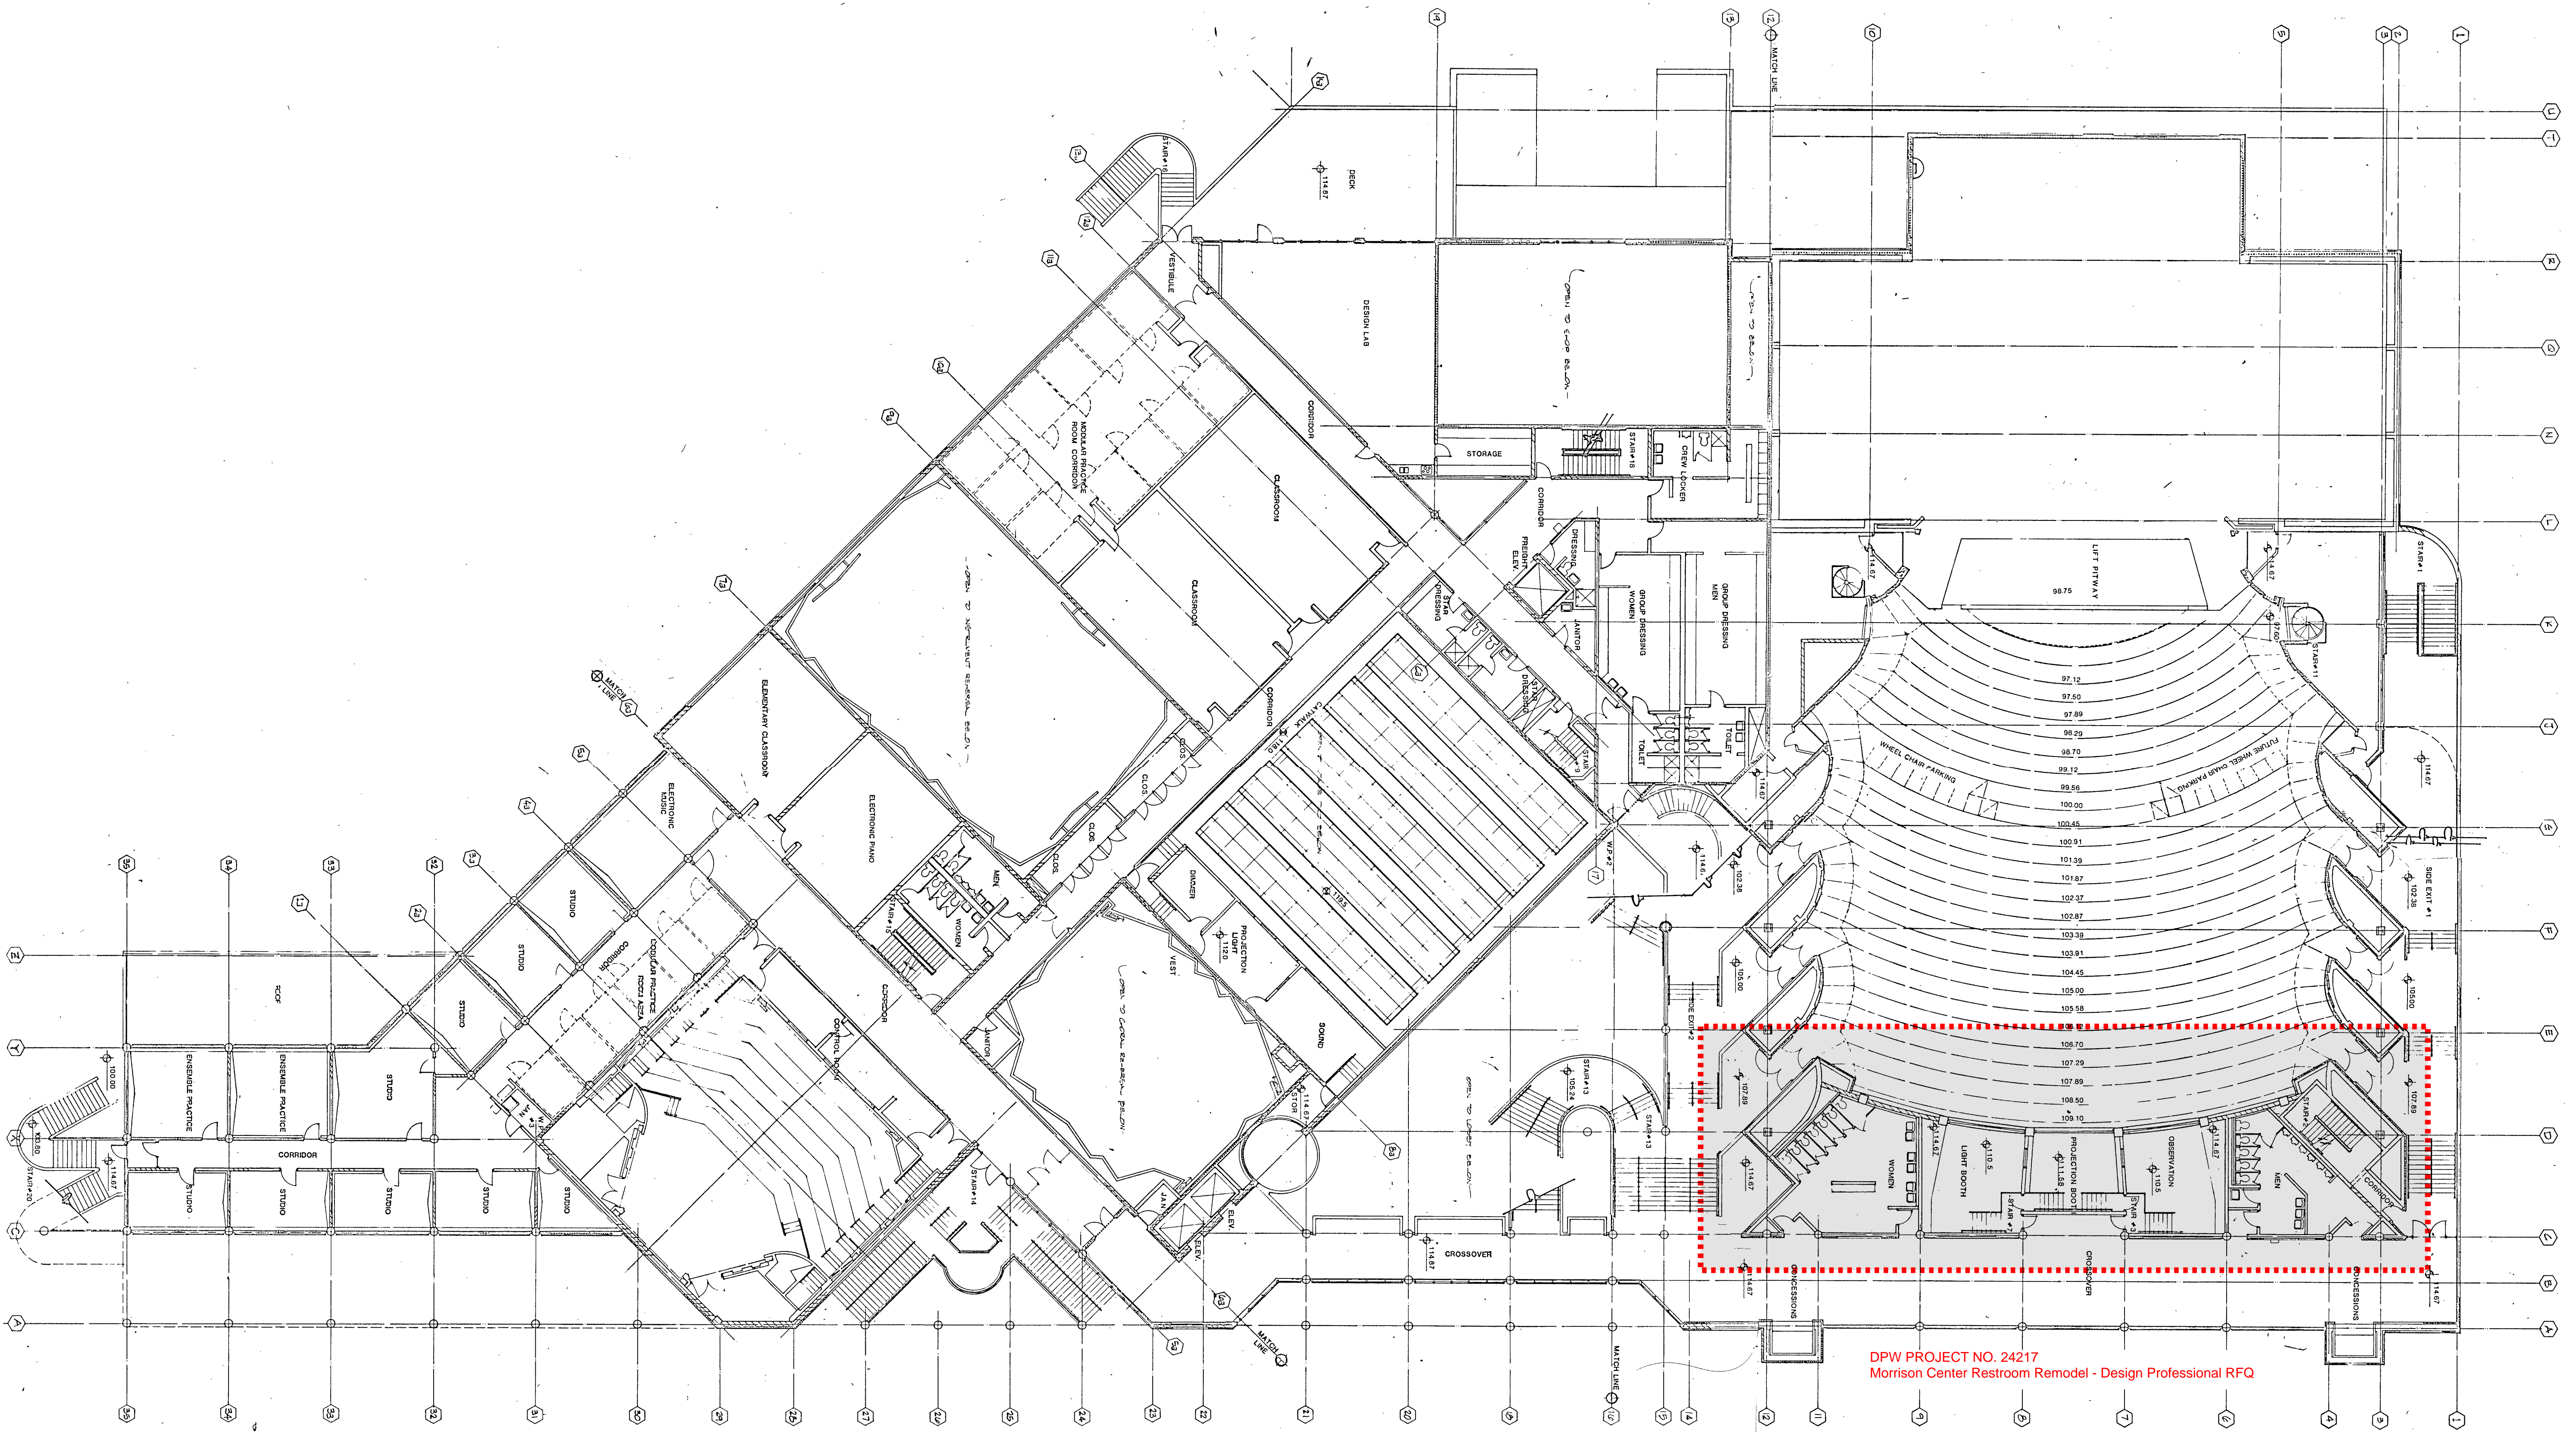

DPW PROJECT NO. 24217  
Morrison Center Restroom Remodel - Design Professional RFO


FLOOR PLAN  
114.67' LEVEL

SCALE 1/16" = 1'-0"

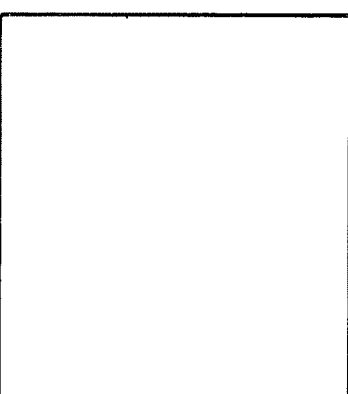

**LOMBARD-CONRAD, ARCHITECTS**  
A.I.A.  
Consultants  
Phone 208-345-6677


Planners  
Boise, Idaho 83706

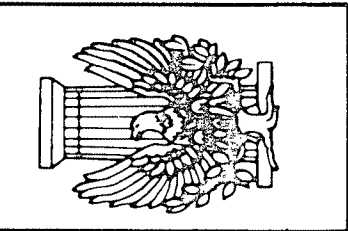

**MORRISON CENTER**  
FOR THE FINE  
AND PERFORMING ARTS  
BOISE STATE UNIVERSITY  
BOISE IDAHO

job no.	79127
date	AUGUST 1981
drawn by	checked by
revisions	date

sheet no.  
**2**  
of 4 sheets

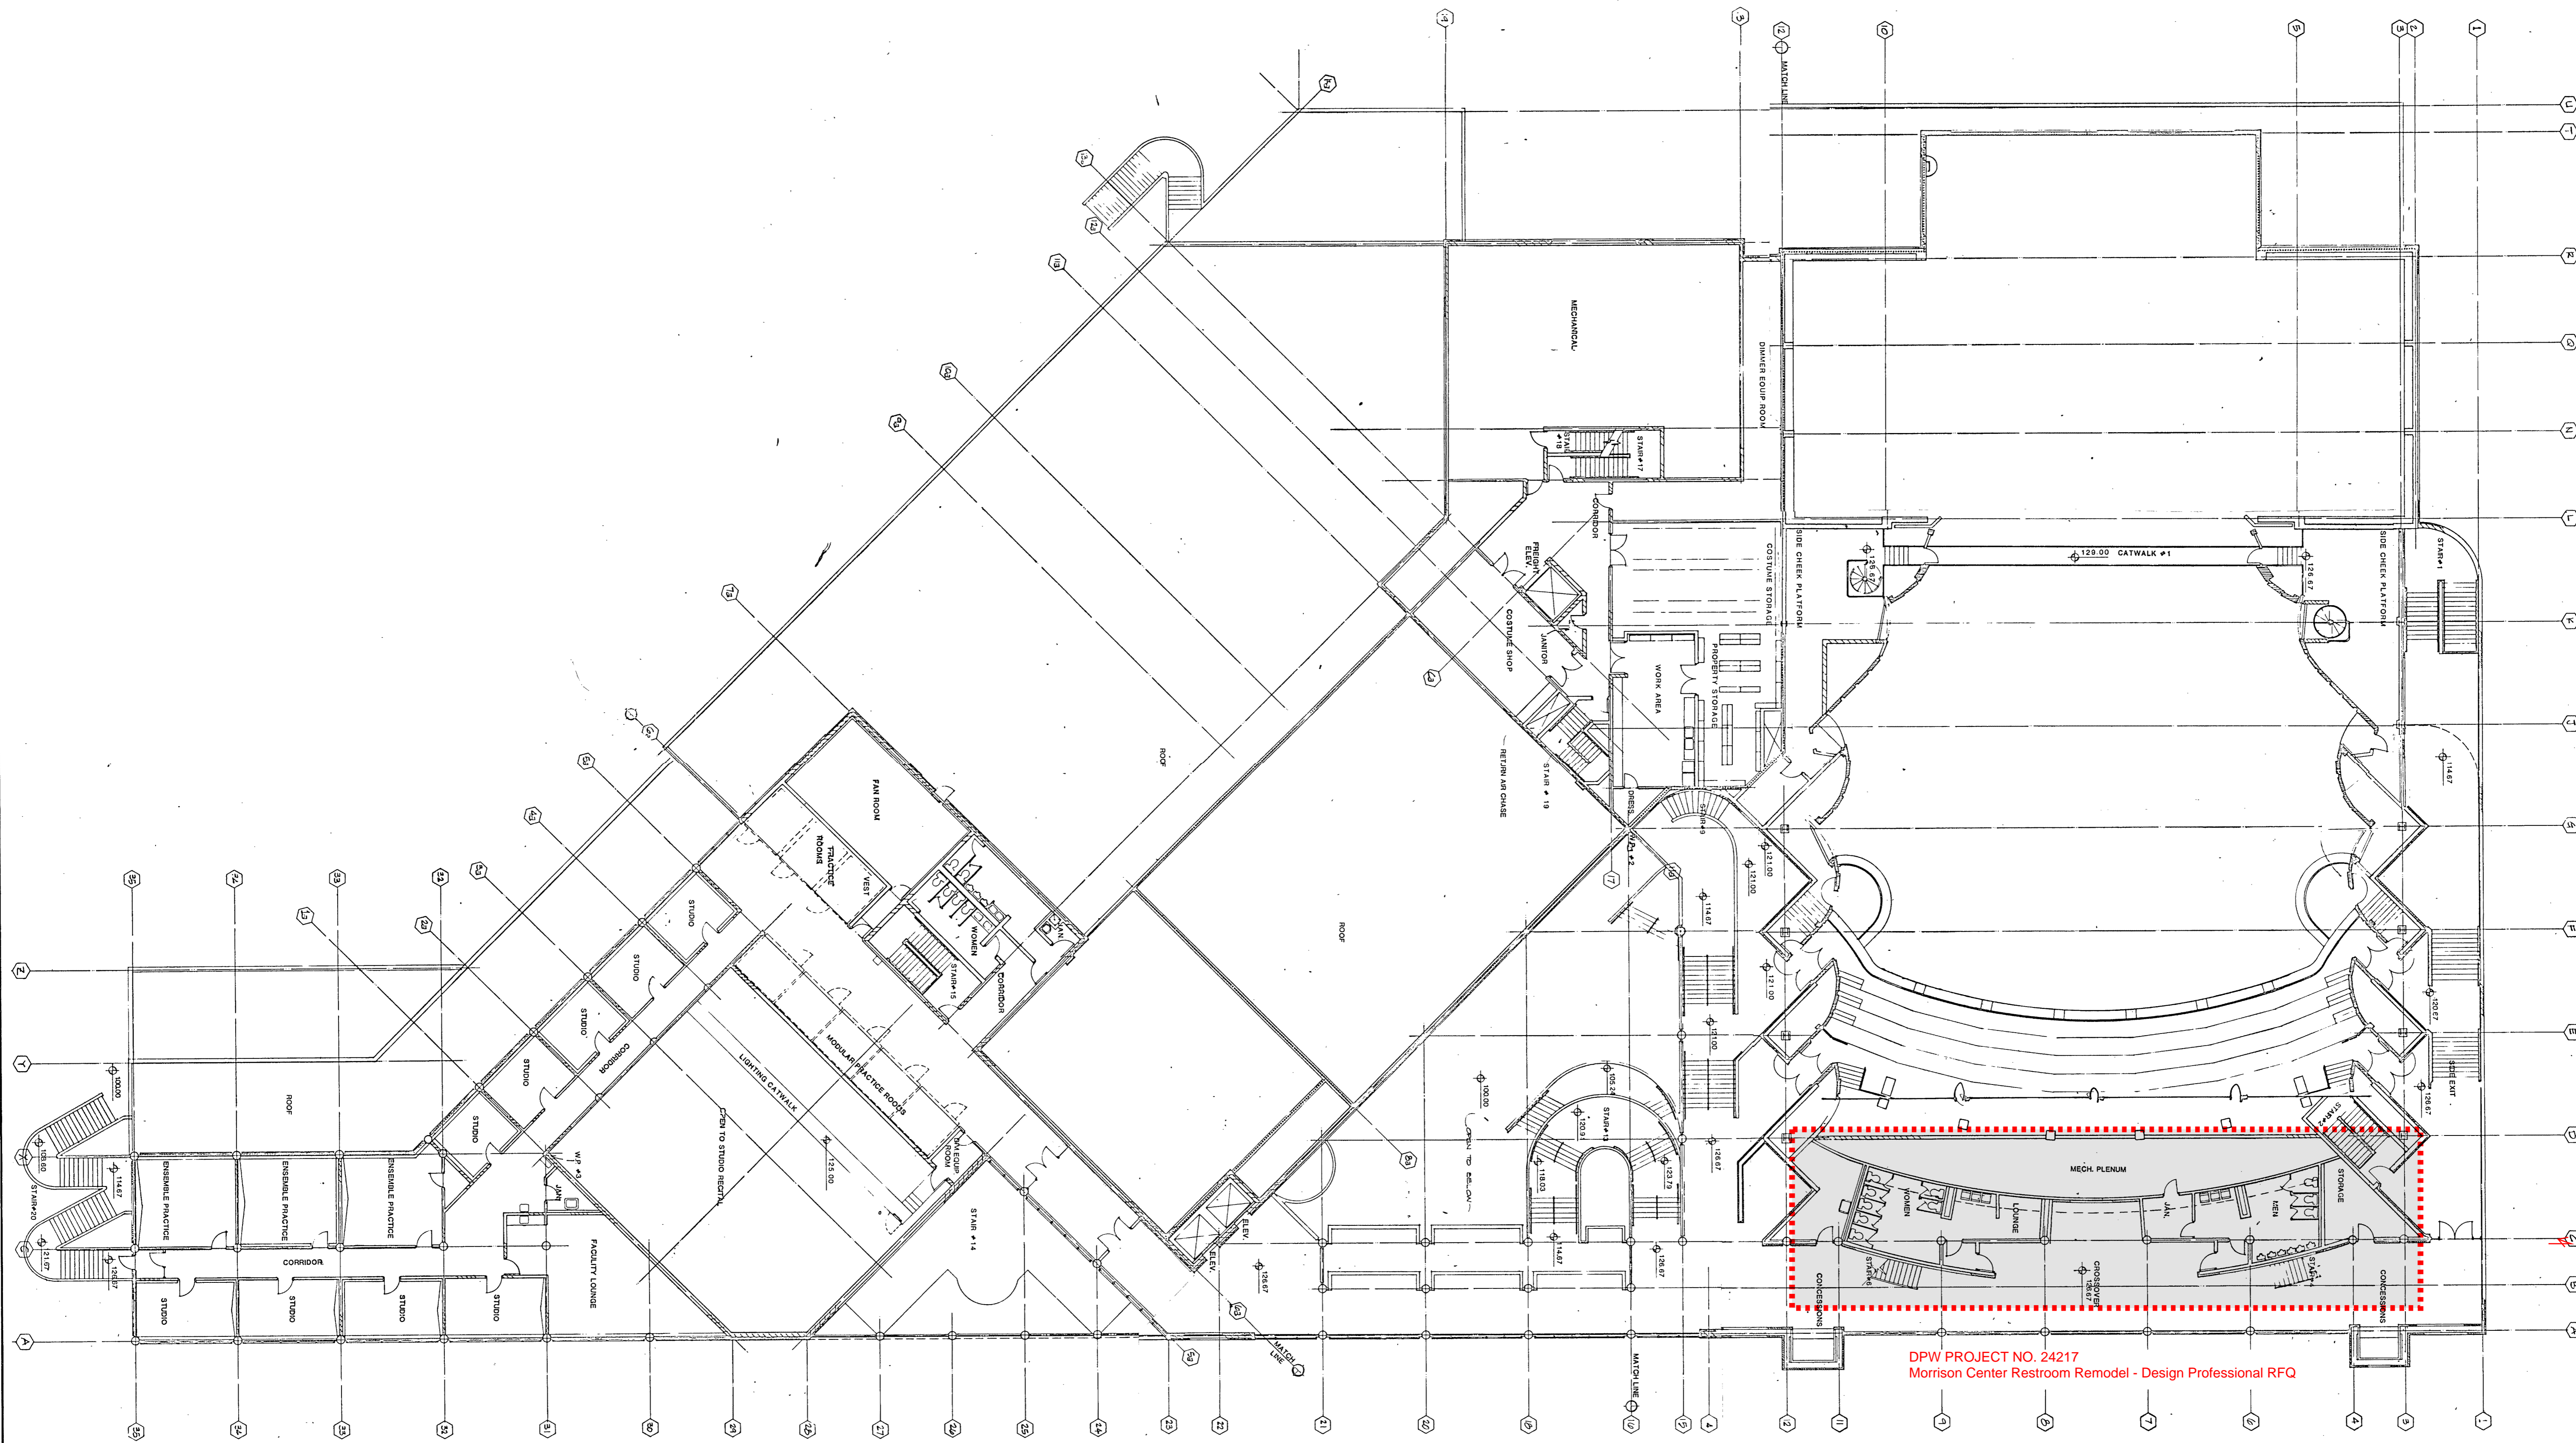


DPW PROJECT NO. 24217  
 Morrison Center Restroom Remodel - Design Professional RFQ

**FLOOR PLAN**  
 126.67' LEVEL

SCALE 1/16" 1'-0"

**LOMBARD-CONRAD, ARCHITECTS**  
 A.I.A.  
 Architects  
 102 South 27th Street, Boise, Idaho 83706  
 Phone 208-345-6677

**PLANNERS**  
 Architects  
 102 South 27th Street, Boise, Idaho 83706  
 Phone 208-345-6677

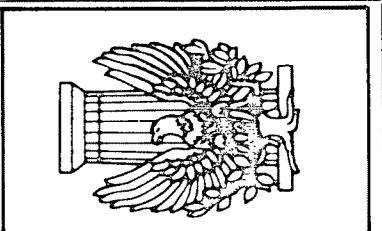

**MORRISON CENTER**  
**FOR THE FINE**  
**AND PERFORMING ARTS**  
 BOISE STATE UNIVERSITY  
 BOISE, IDAHO

job no.	79/27
date	AUGUST 1981
drawn by	checked by
revisions	date

sheet no.  
 3  
 of 4 sheets